


THESE DRAWINGS PROVIDE A GENERIC OVERVIEW OF THE INSTALLATION. THEY ARE NOT PROJECT SPECIFIC OR REFLECT ANY CUSTOMIZATION UNLESS NOTED. PLEASE CONTACT VORTEX AQUATIC STRUCTURES INTERNATIONAL FOR MORE DETAILS.


PLAN VIEW

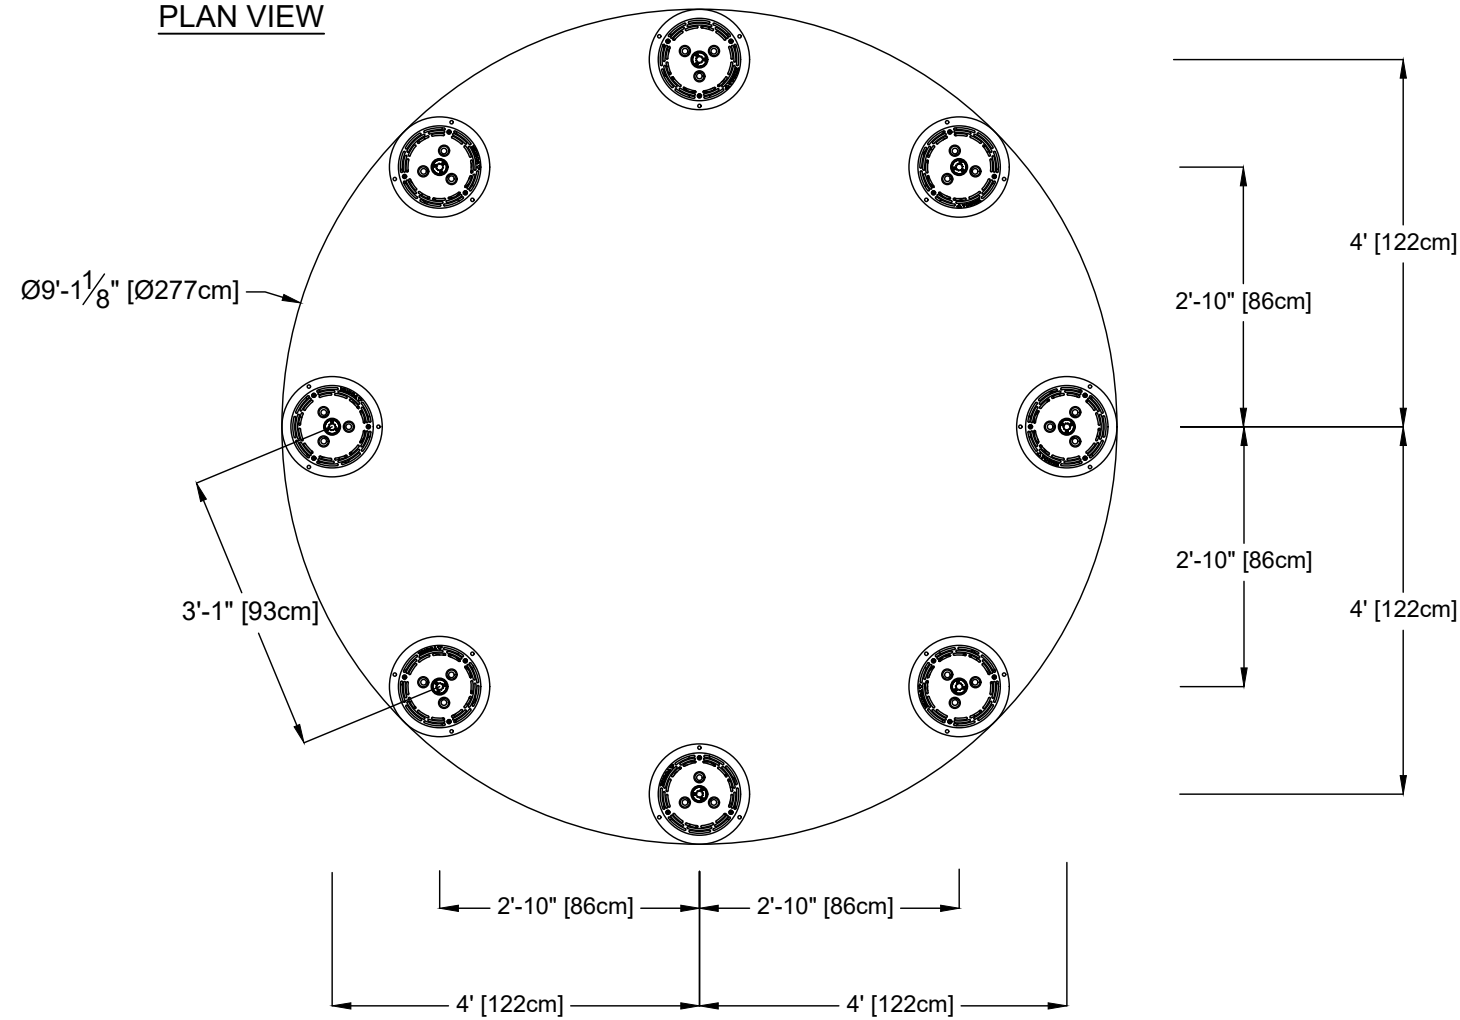


NOTES:

- 1) SEE THE PIPING AND CONNECTION DIAGRAM FOR PLACEMENT AND DRAINAGE NEEDED.
- 2) DISTANCE BETWEEN JETS CAN BE CHANGED, BUT WATCH OUT FOR SPRAYZONE CHANGE. AGAIN REFER TO PIPING AND CONNECTION DIAGRAM
- 3) JET & LIGHT CHOREOGRAPHY REQUIRES A WATER MANAGEMENT SYSTEM WITH FAST ACTING VALVES (FAV)

FRONT ELEVATION VIEW

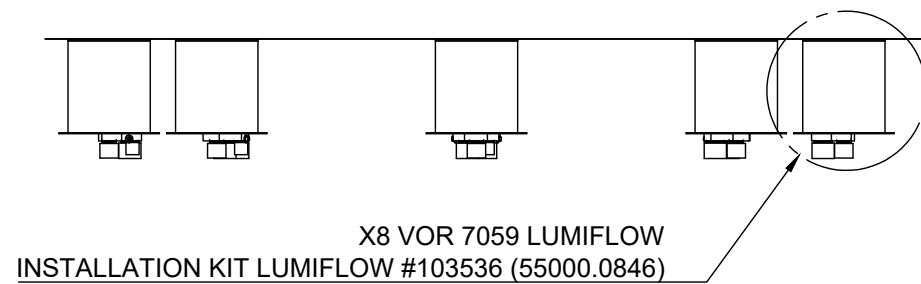

SIDE ELEVATION VIEW

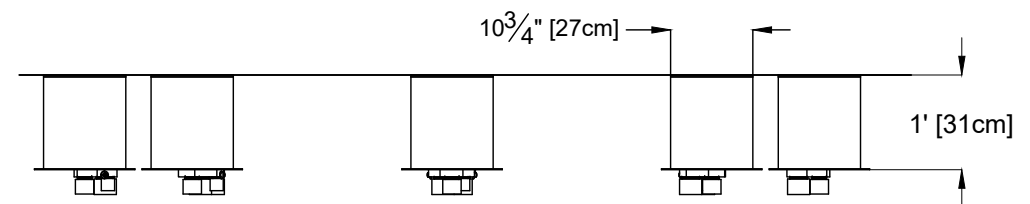

PRODUCT NAME: COREOPLAY FIREWORK

PRODUCT NUMBER: VOR 7064

DATE: 13-02-2023

SHEET NO: 1/1

11"x17" SHEET SIZE

