


PLAN VIEW

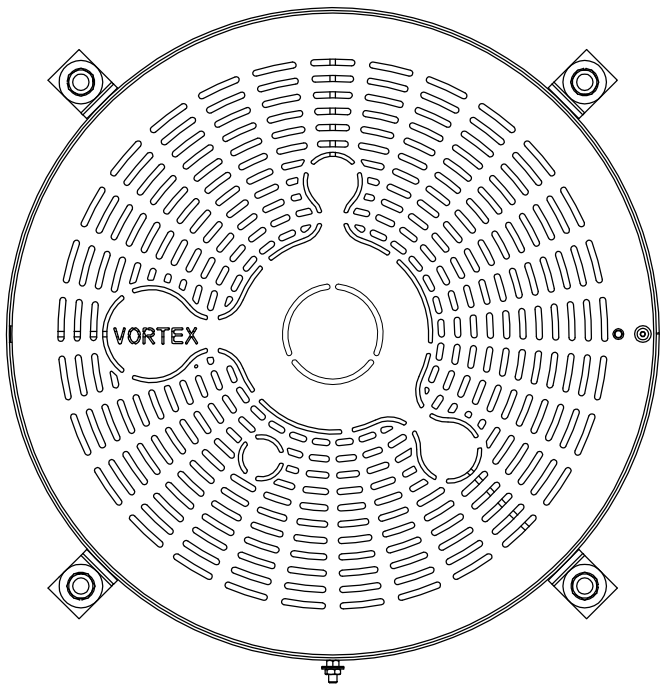

EXPANDED POLYPROPYLENE DRAIN BOX FOAM (BY VORTEX)

ANCHORING SYSTEM TO BE INSTALLED LEVEL, PLUMB
& FLUSH TO FINISHED GRADE(BY INSTALLER)

CONCRETE SURFACE. VERIFY LOCAL CODES
FOR TYPE, THICKNESS & REINFORCEMENT
REQUIREMENTS(BY INSTALLER)


STRAINER BASKET
(SOLD SEPARATELY)

4 X 3/4" (20mm) S.S. HEIGHT & LEVELING CONTROL
ANCHOR STUDS WITH HARDWARE.(BY VORTEX)
DRILL & EPOXY GROUT STUDS (DONE BY INSTALLER)

3/8" (10mm) EARTH
GROUNDING STUD

WATER LINE OUTLET 8 5/8" (219mm). MIN. 2% SLOPE.
(LINE CONNECTION SUPPLIED BY INSTALLER)

FRONT ELEVATION VIEW

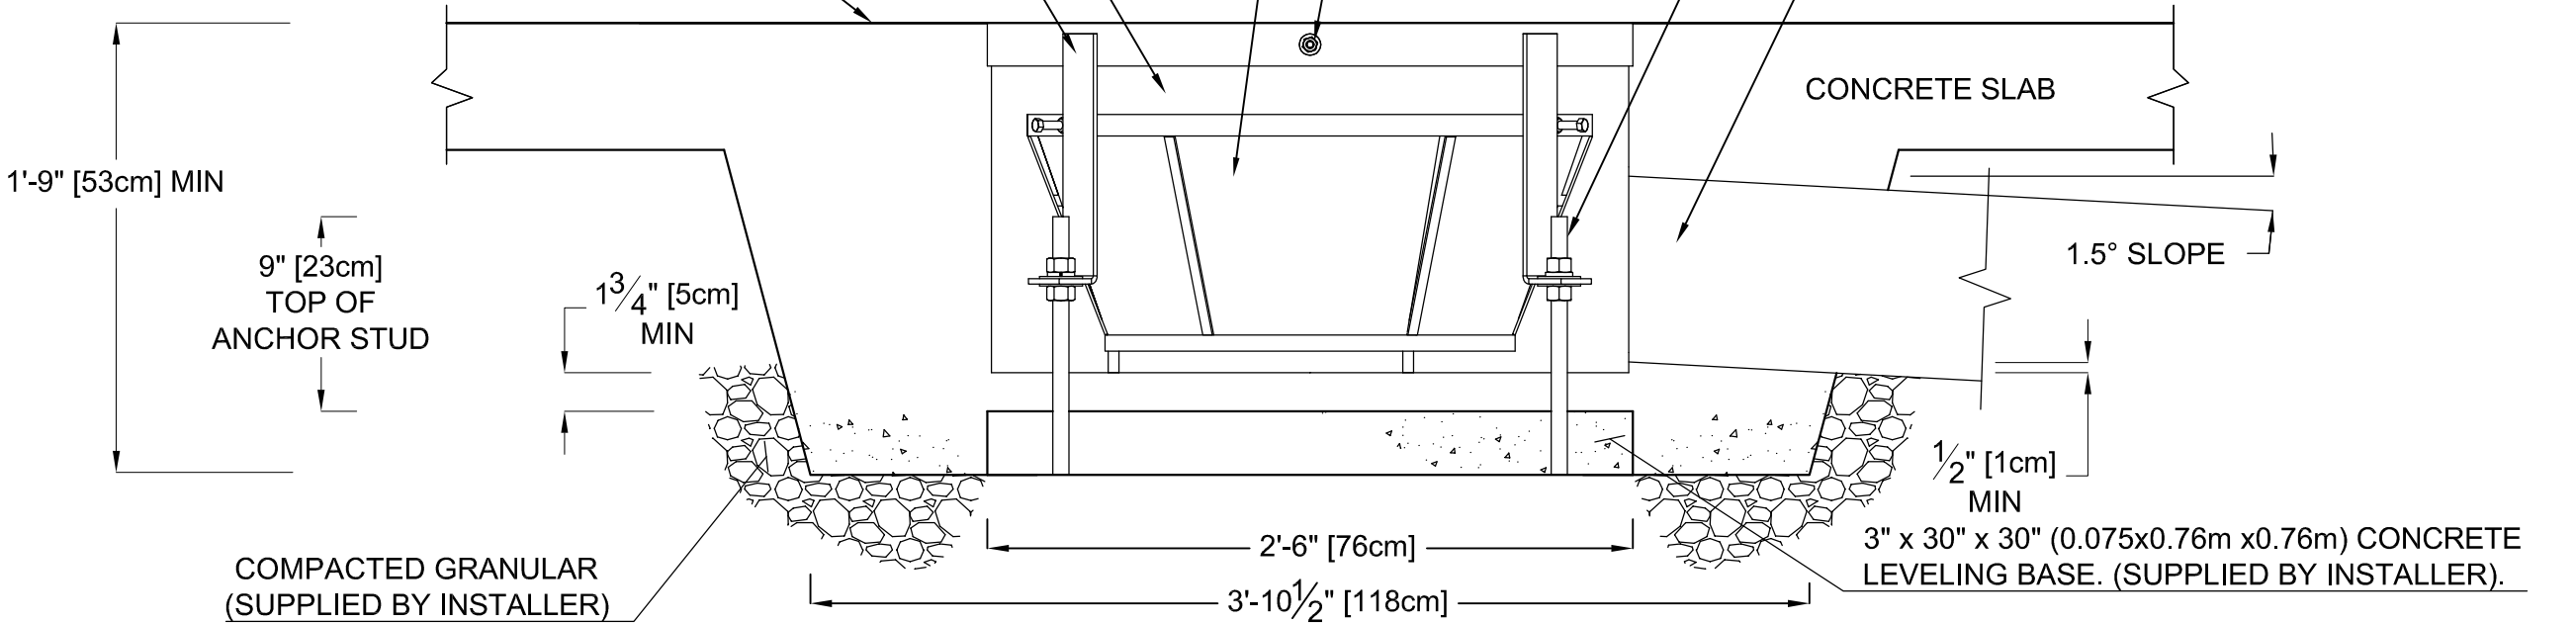

VOR-1001.4000 PLAYSAFE DRAIN, No1 (Construction Detail)

PRODUCT NAME: PLAYSAFE DRAIN, No1

PRODUCT NUMBER: VOR-1001.4000

PRODUCT INFORMATION

DATE: 07/29/11

SHEET NO: 1/1

11"x17" SHEET SIZE

