

PLAN VIEW


Note:
1- Cover plate must be install during concrete pouring.

$\frac{3}{8}$ " (10mm) BONDING STUD

ANCHORING SYSTEM TO BE INSTALLED LEVEL, PLUMB
& FLUSH TO FINISHED GRADE(BY INSTALLER)

4 X 1/2" (13mm) S.S. HEIGHT & LEVELING CONTROL
ANCHOR STUDS WITH HARDWARE.(BY VORTEX)
DRILL & EPOXY GROUT STUDS (DONE BY INSTALLER)

FRONT ELEVATION VIEW

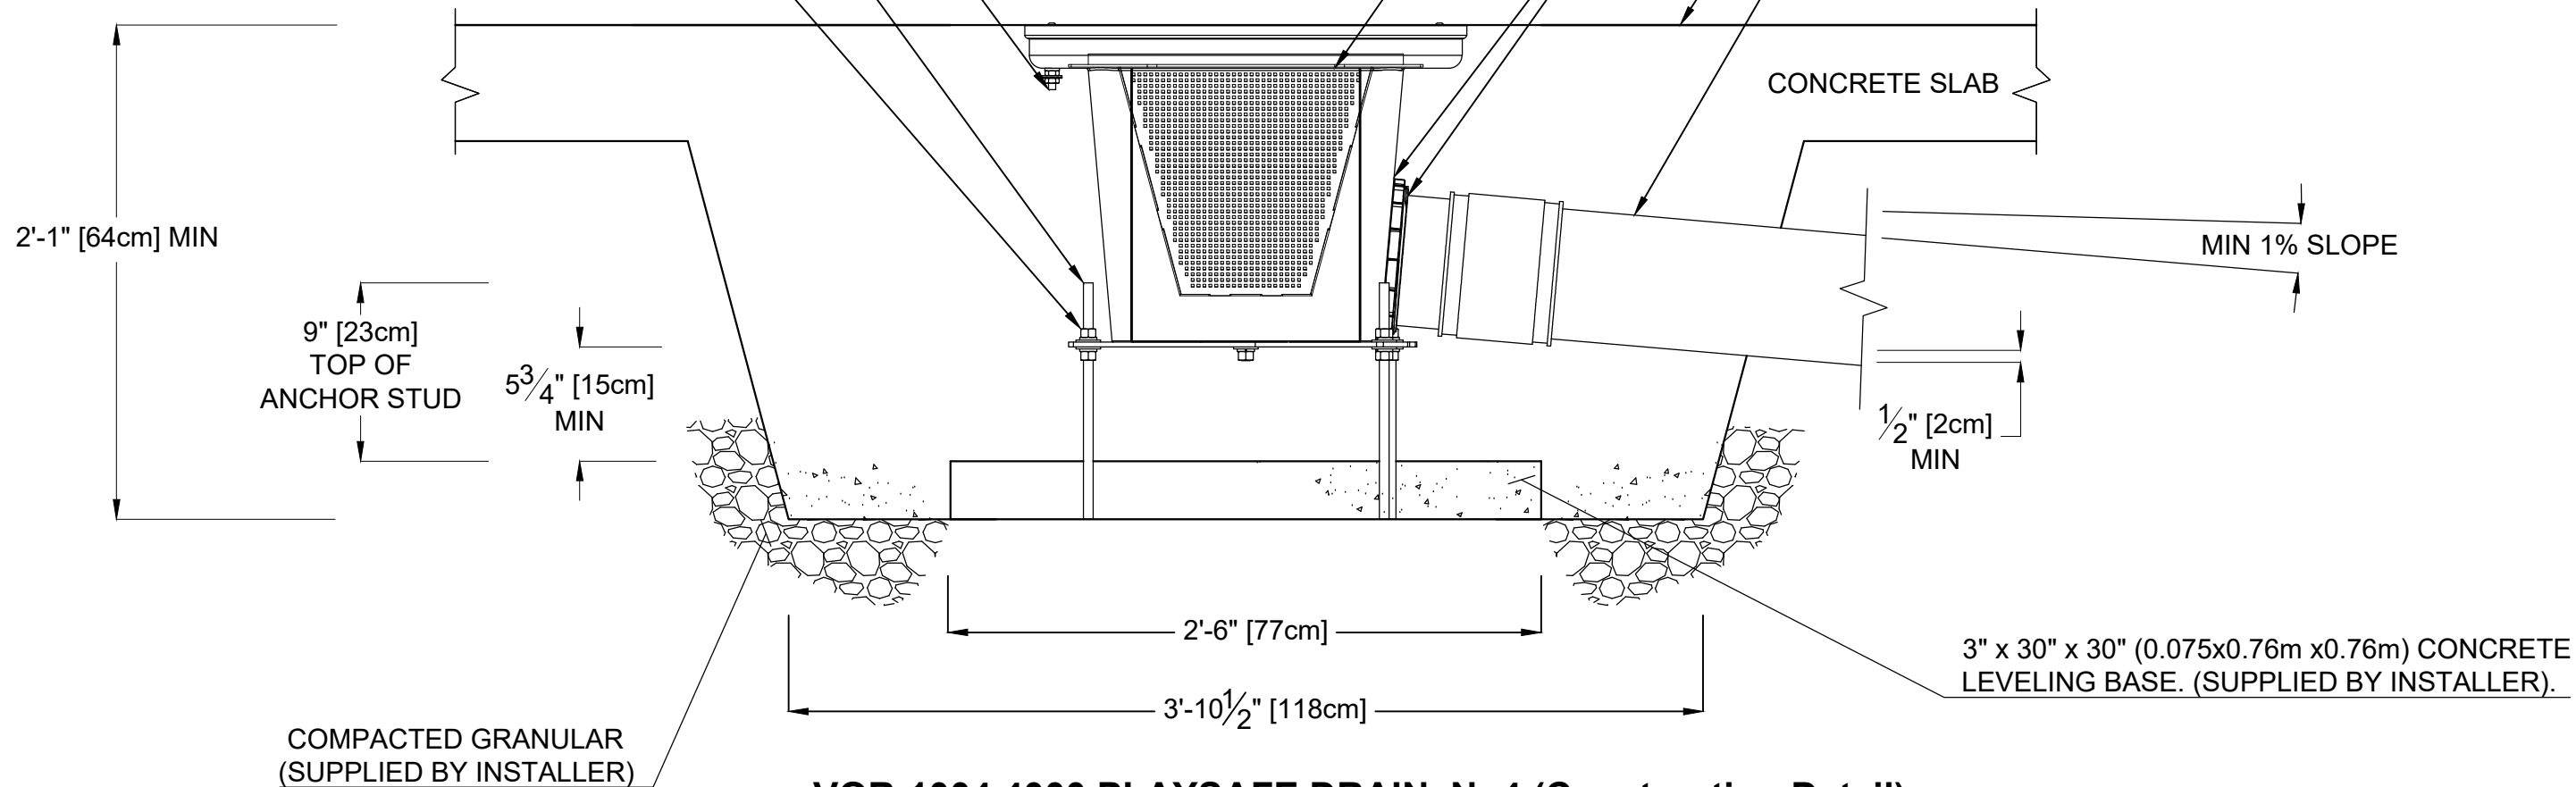

VOR-1004.4000 PLAYSAFE DRAIN, No4 (Construction Detail)

PRODUCT NAME: PLAYSAFE DRAIN, No4

PRODUCT NUMBER: VOR-1004.4000

PRODUCT INFORMATION

DATE: 11/17/20

SHEET NO: 1/1

11"x17" SHEET SIZE

